

CFM FLEX DUCT CHART


4/5"	30-75
6"	75-100
8"	200-250
9"	250-350
10"	300-400
12"	450-600
14"	600-1000
16"	1000-1200
18"	1200-1600
20"	1600-2000

REYNOLD RESIDENCE
PARCEL #
179-04-503-001

L&S Air Conditioning
Lic # 40987

Issue Date: MARCH-28/2021
 DRAWN BY: LEO SANTORO JR
 Project # 21-065

STAMP

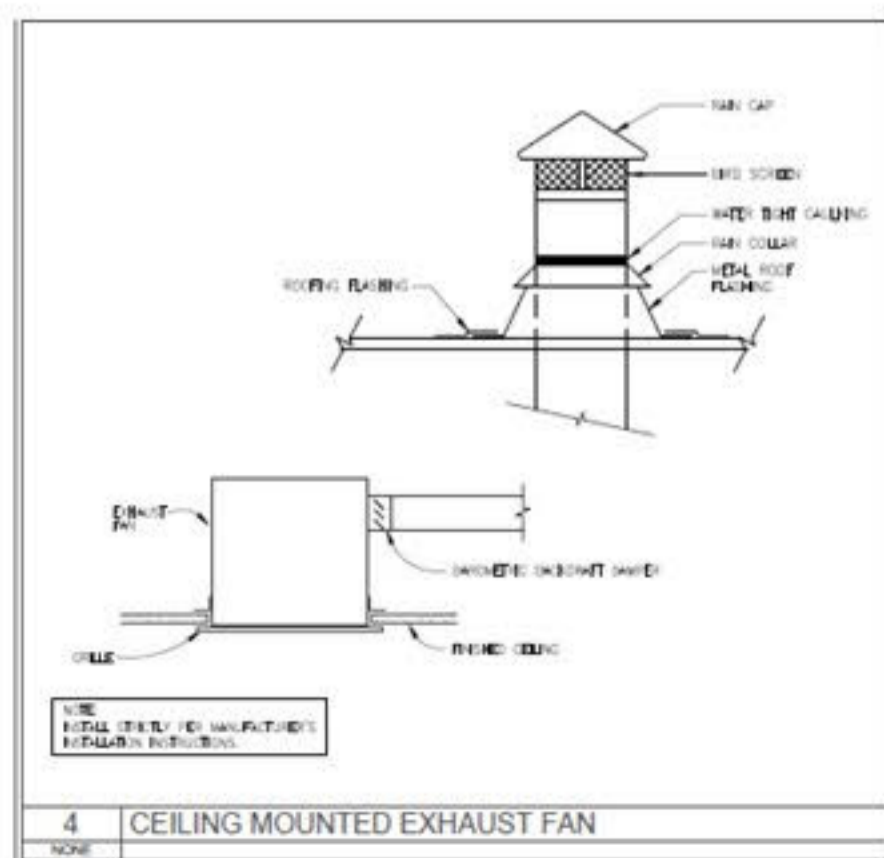


EQUIPMENT	TONNAGE/ VOLT	
FAU-CU-1 4.0TON	4.0	208/1
FAU-CU-2 3.0 TON	3.0	208/1
FAU-CU-3 2.0 TON	2.0	208/1
FAU-CU-4 4.0 TON	5.0	208/1

EXHAUSTED FANS	VOLT
EF-1 BROAN	120/1
EF-2 OVERN RANGE 3"	

M Mechanical Plan

Scale 1/4" X 1'

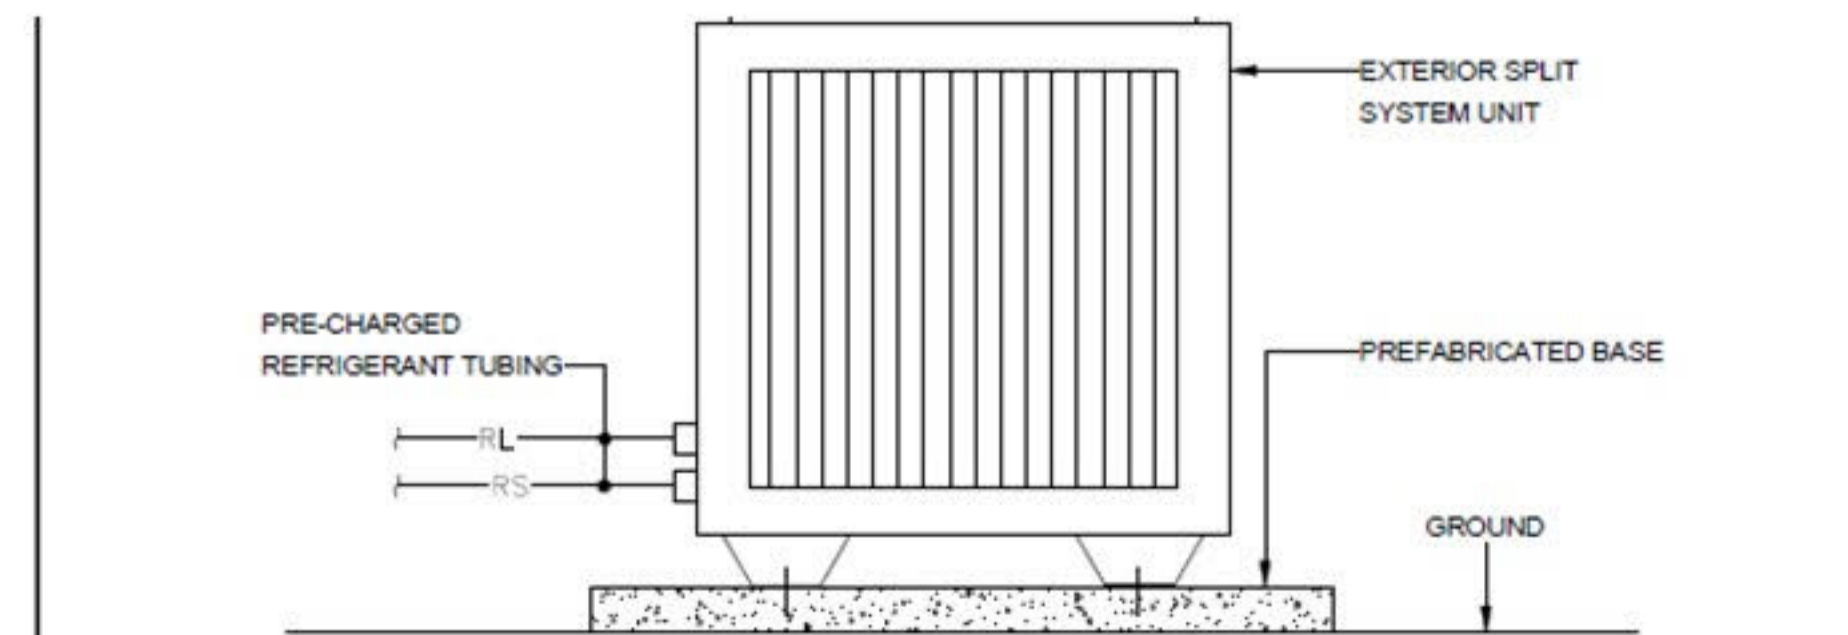

3 EXTERIOR SPLIT SYSTEM MOUNTING DETAIL

NO SCALE

M-1